


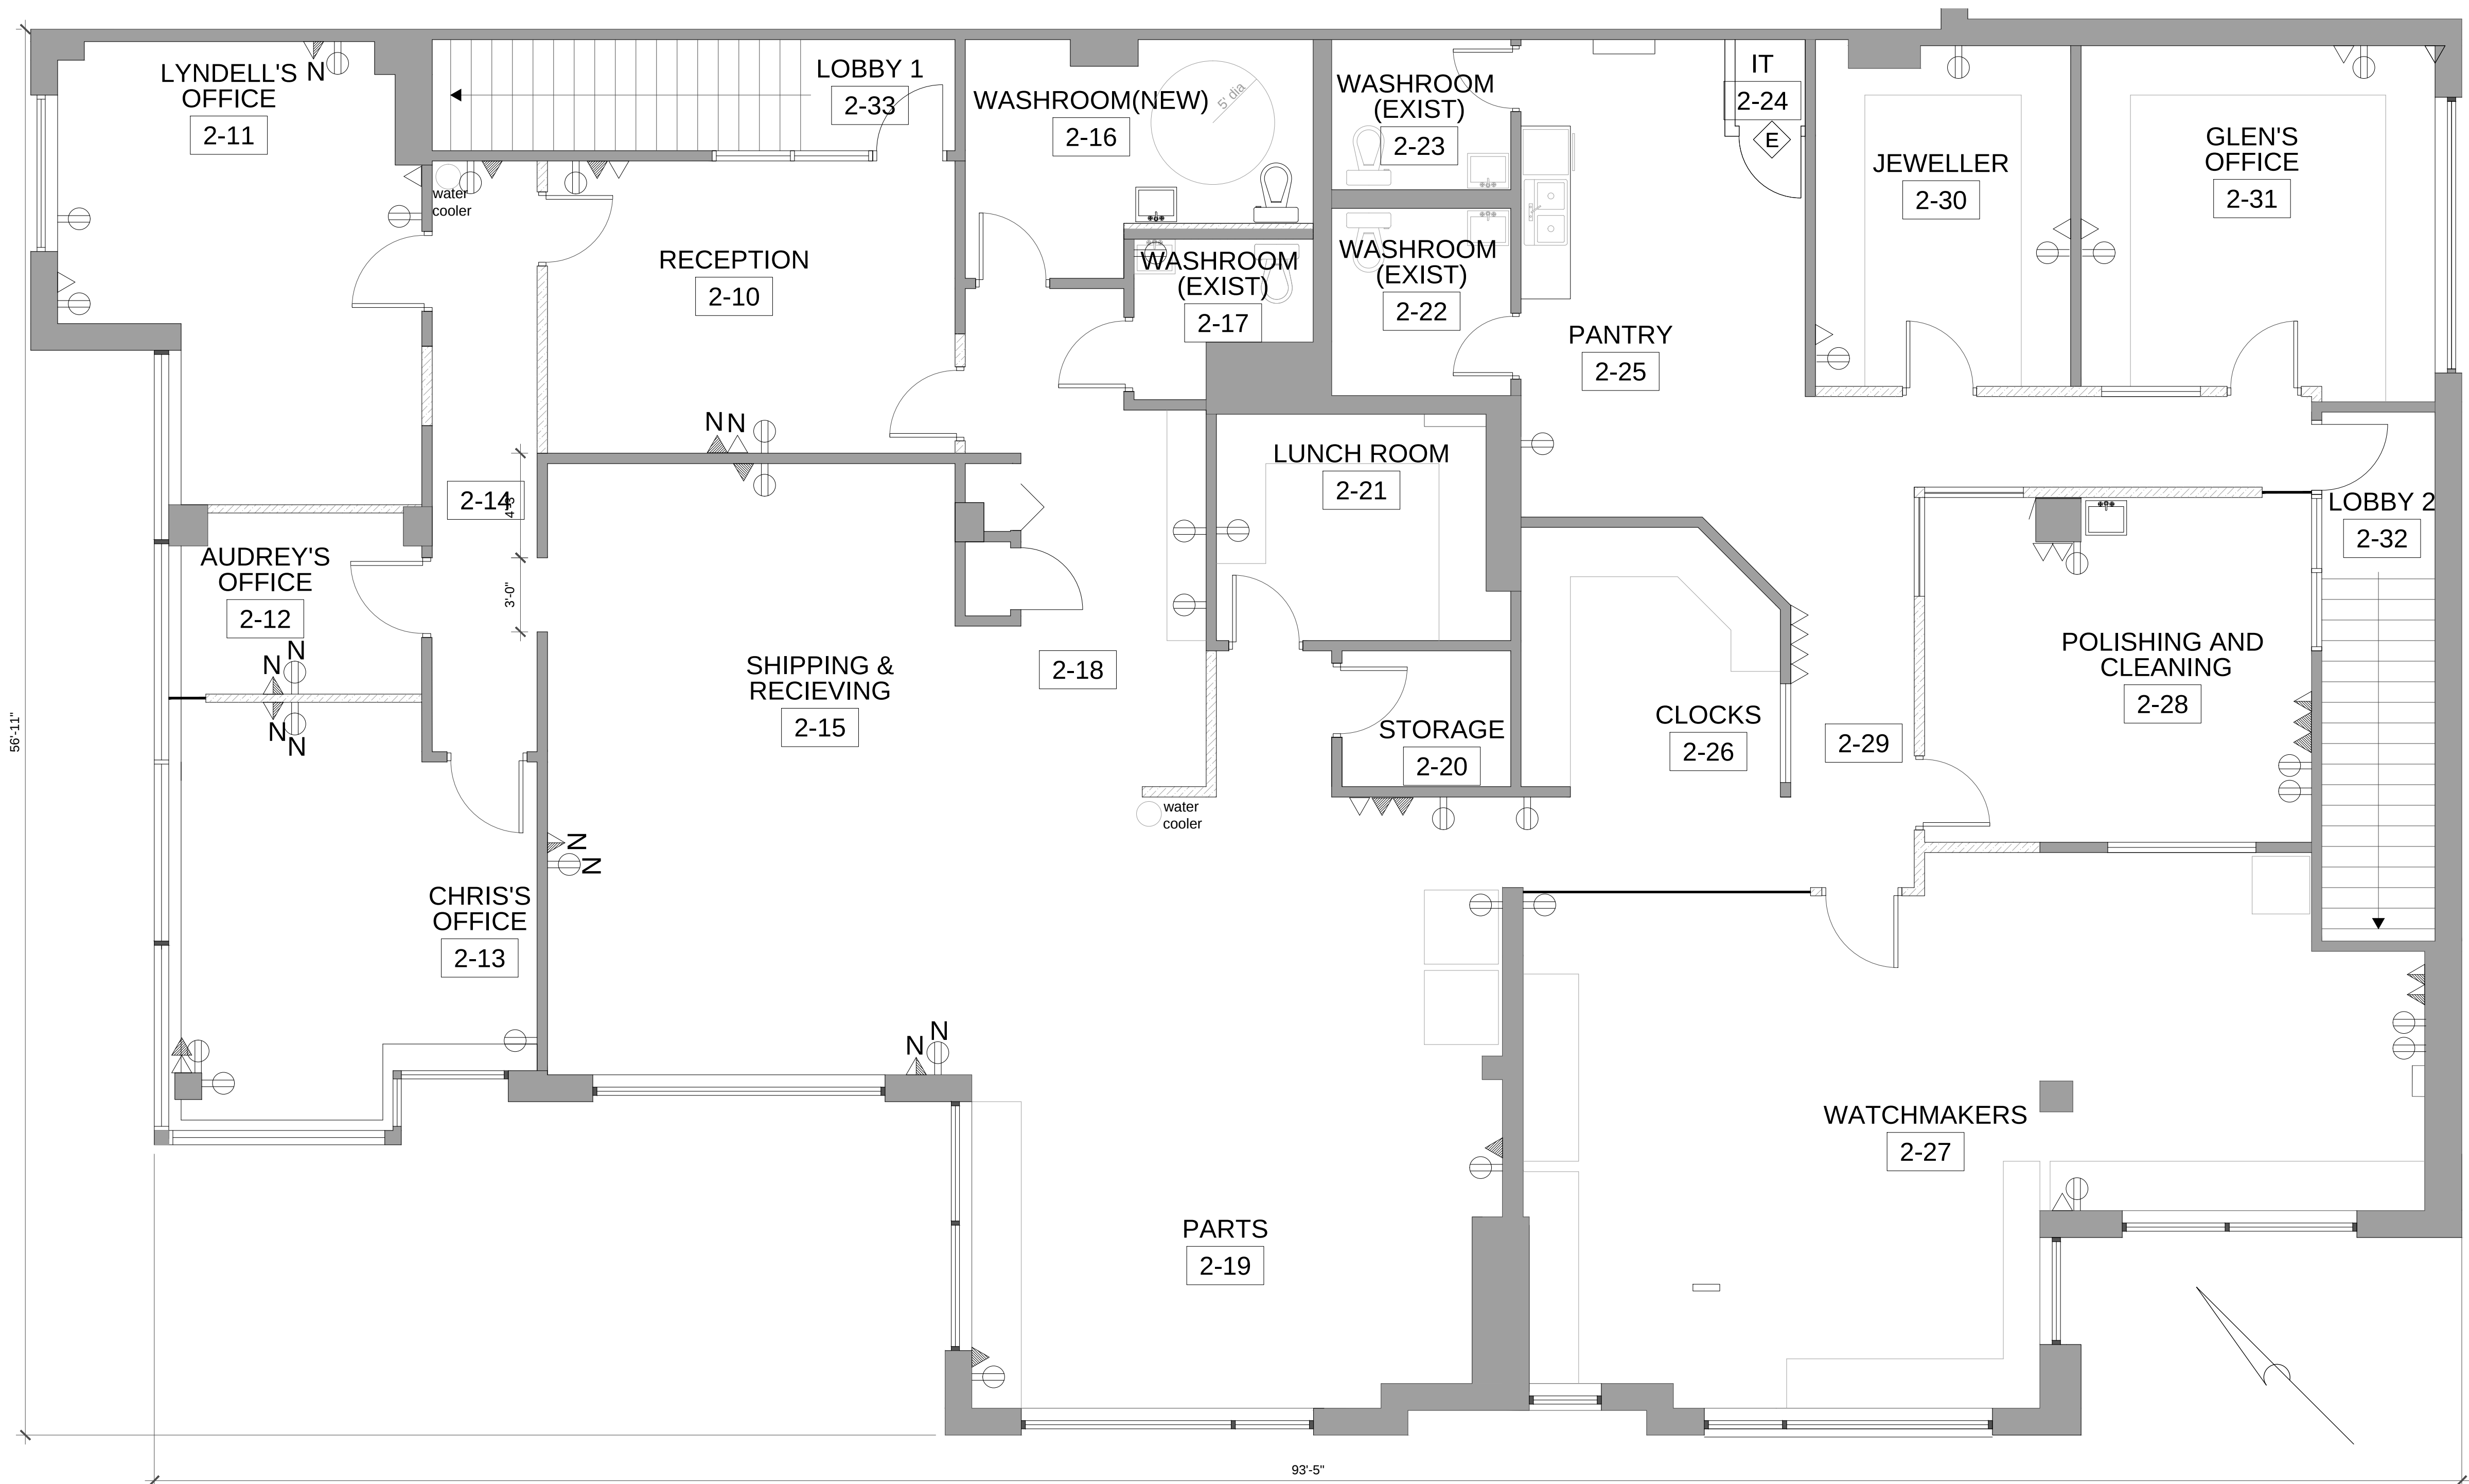

POWER & COMMUNICATION LEGEND

- AREA NOT IN CONTRACT (N.I.C.).
- WALL MOUNTED DUPLEX RECEPTACLE
- WALL MOUNTED SPLIT DUPLEX RECEPTACLE
- WALL MOUNTED DUPLEX RECEPTACLE ABOVE COUNTER
- CEILING MOUNTED DUPLEX RECEPTACLE
- INDICATES DIRECT CONNECTION TO EQUIPMENT, i.e., DISHWASHER
- FLOOR MOUNTED DUPLEX RECEPTACLE
- WALL MOUNTED DATA OUTLET
- WALL MOUNTED TELEPHONE OUTLET
- WALL MOUNTED COMBINATION TELEPHONE/DATA OUTLET
- WALL MOUNTED CABLE TV OUTLET
- GROUND FAULT INTERRUPTER
- DEDICATED CIRCUIT
- DEDICATED CIRCUIT FOR HOUSEKEEPING
- WALL MOUNTED COMBINATION OUTLET (2) DUPLEX OUTLET (1) DATA OUTLET (1) TELEPHONE OUTLET
- FURNITURE PANEL COMBINATION OUTLET (2) DUPLEX OUTLET (1) DATA OUTLET (1) TELEPHONE OUTLET
- FLOOR MOUNTED COMBINATION OUTLET (2) DUPLEX OUTLET (1) DATA/ TELEPHONE OUTLET (1) HDMI
- INDICATES HARD WIRED WALL MOUNTED CONNECTION TO SYSTEMS FURNITURE PANELS
- INDICATES HARD WIRED FLOOR MOUNTED CONNECTION TO SYSTEMS FURNITURE PANELS
- NUMBER INDICATES THE NUMBER OF STATIONS TO BE SUPPLIED WITH THE ABOVE REQUIREMENTS
- NEW WALL MOUNTED CARD ACCESS CW MAG LOCK OR ELECTRIC STRIKE
- INDICATES DOORS TO HAVE ELECTRIC STIKES WITH KEYED OVERRIDE
- INDICATES DOORS TO HAVE ELECTROMAGNETIC LOCKS
- INDICATES FIRE PULL STATION
- INDICATES PUSH BUTTON RELEASE FOR ELECTROMAGNETIC LOCK AND/OR AUTO OPERATOR DOORS.
- NEW ELECTRICAL PANEL. PROVIDE 4'X6' FIRE PLY BEHIND
- POWER POLES

POWER & COMMUNICATION NOTES

- DUPLEX RECEPTACLE TO BE @18" AFF. UNLESS OTHERWISE NOTED.



223-1118 HOMER STREET
VANCOUVER, BC. V6B 2X6
604.683.8407
www.counterpoints.com

COPYRIGHT RESERVED
ALL PARTS OF THIS DRAWING ARE THE EXCLUSIVE PROPERTY OF COUNTERPOINT PROJECTS INC AND MAY NOT BE REPRODUCED WITHOUT DESIGNERS CONSENT.

THIS DRAWING MUST NOT BE SCALED. THE GENERAL CONTRACTOR SHALL VERIFY AND CHECK ALL DIMENSIONS AND IS RESPONSIBLE TO REPORT ALL ERRORS AND OMISSIONS PRIOR TO THE COMMENCEMENT OF ANY WORK.

ON TIME SERVICE CORP.
251 & 252 - 5489 BRYNE RD.
BURNABY, BC. V5J 3J1

10				
9				
8				
7				
6				
5				
4				
3				
2	2019-08-xx	FOR BUILDING PERMIT		
1	2019-08-19	FOR LANDLORD REVIEW	1	
NO.	DATE	ISSUED		REV.
PROJECT NO.: 19115				
DRAWN: NA		CHECKED: NA		
ISSUED: BUILDING PERMIT				
SCALE: 1/8"=1'-0"				
TITLE: POWER & COMMUNICATIONS PLAN				
NORTH: 		DWG. NO.: ID6.0		